


16/06/2022 17:03:49

LEGEND / LEGENDA


- Abvalwaterafvoer / Waste Water Drainage
- Industriële / condensaatwaterafvoer / Industrial / Condensate Water Drainage
- R/E Inspectieluik / Rodding eye

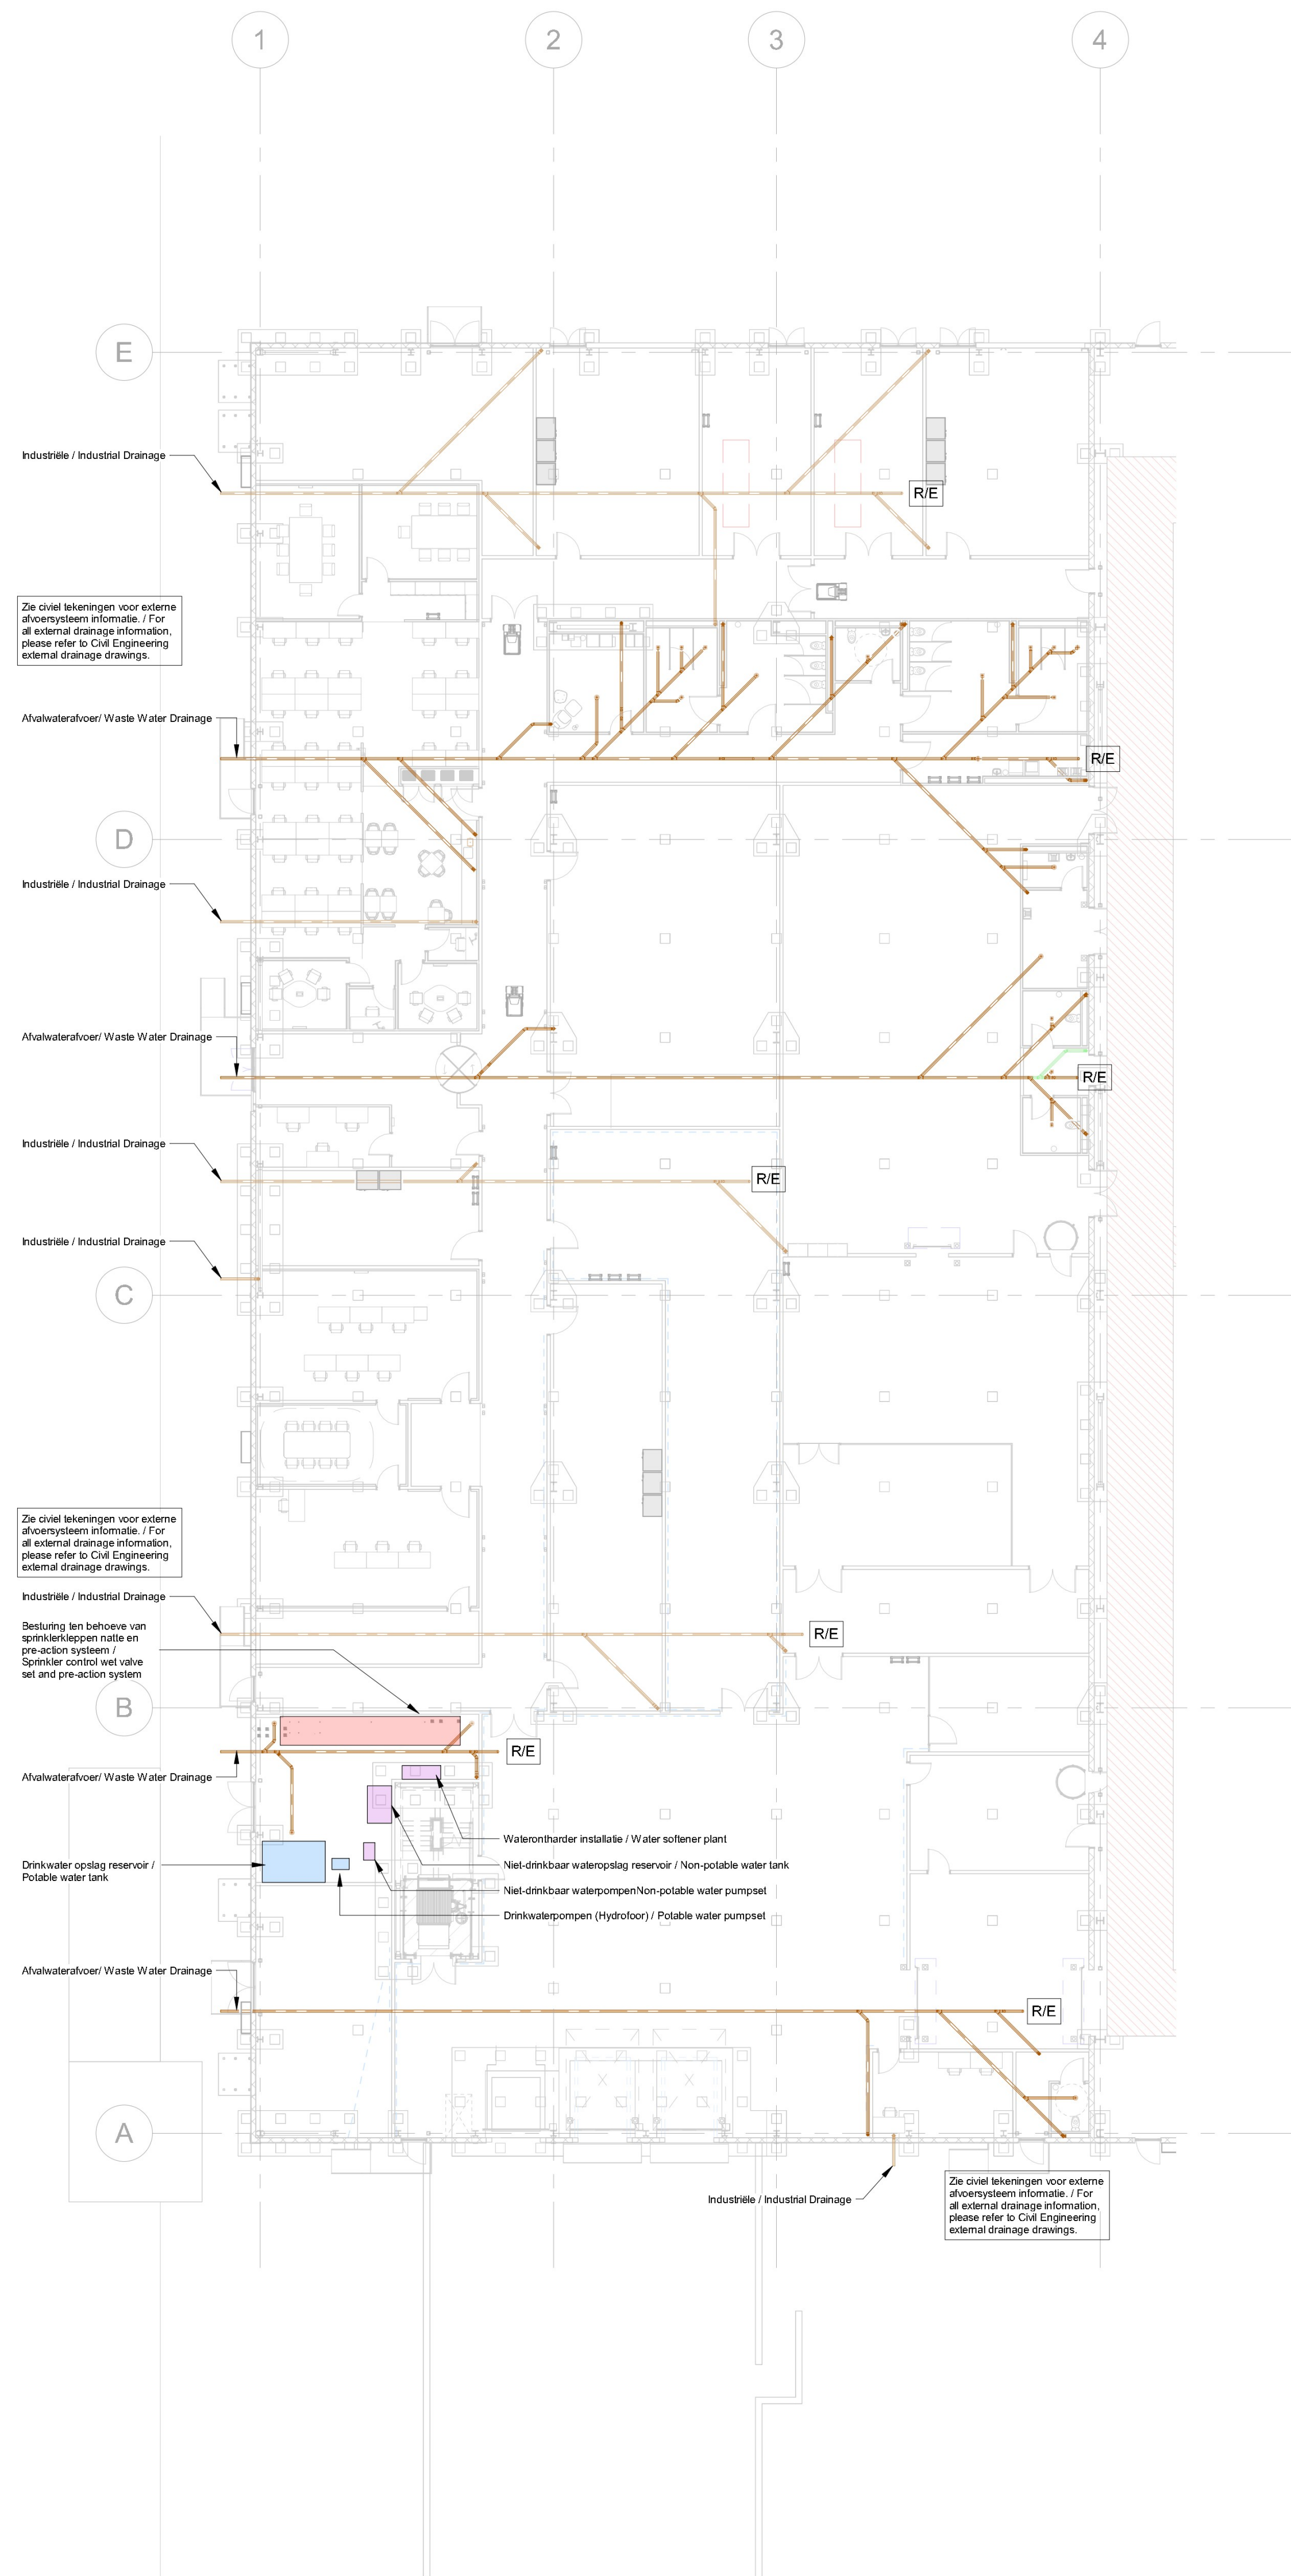

BOUWKUNDIG / ARCHITECTURE:	CONSTRUCTIE / STRUCTURE:	INSTALLATIE TECHNISCH / MEP:
Arup B.V. Naritaweg 118 1043 CA Amsterdam The Netherlands	Arup B.V. Naritaweg 118 1043 CA Amsterdam The Netherlands	Arup B.V. Naritaweg 118 1043 CA Amsterdam The Netherlands



AANVRAAG OMGEVINGSVERGUNNING /
PERMITTING PACKAGE
(NIET VOOR UITVOERING / NOT FOR CONSTRUCTION)

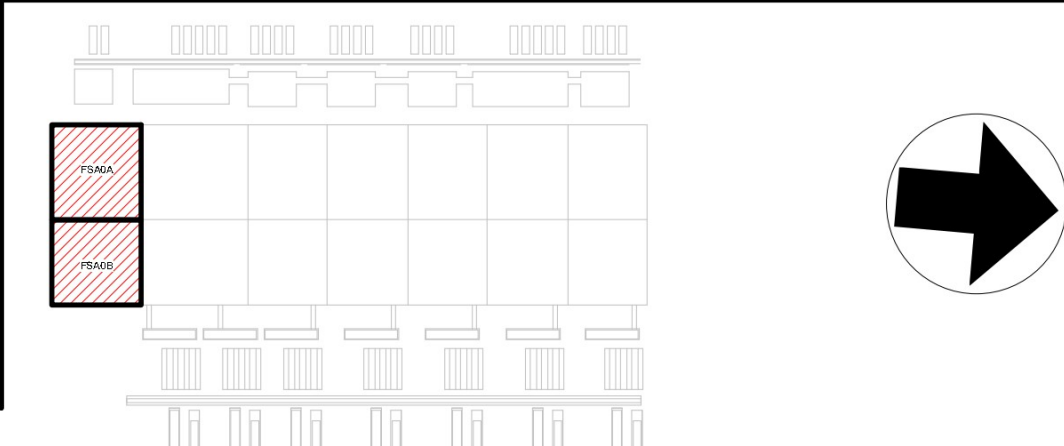

REVISIE / REVISIONS		
NR / NO.	DATUM / DATE	OMSCHRIJVING / DESCRIPTION
0.1	2022-06-16	Omgevingsvergunning Definitief / WABO Permit Issue

Getekend / Drawn By:	
Gecontroleerd / Checked By:	
Goedgekeurd / Approved By:	

DC1A FSA MEP

B. Haitzemastraat
9672 DC Winschoten
Netherlands
Project Nr. / Project No.: 286821-00

FSA Plattegrond Ondergrondse Riolering / FSA
Below Slab Drainage Layout Day N

Discipline / Discipline:
CIVIL

Schaal / Scale: 1 : 200 Formaat / Sheet Size: A0

Tekening Nummer / Sheet Number:
1A-C-1000X-FSA1-0

Huidige Revisie / Current Rev: 0.1
Fase / Phase: PERMITTING
Model Naam / Model Name: 1A-FSA-MEP
Bestandsformaat / Native File Format: Revit V. 2022.1