




16/06/2022 16:48:13

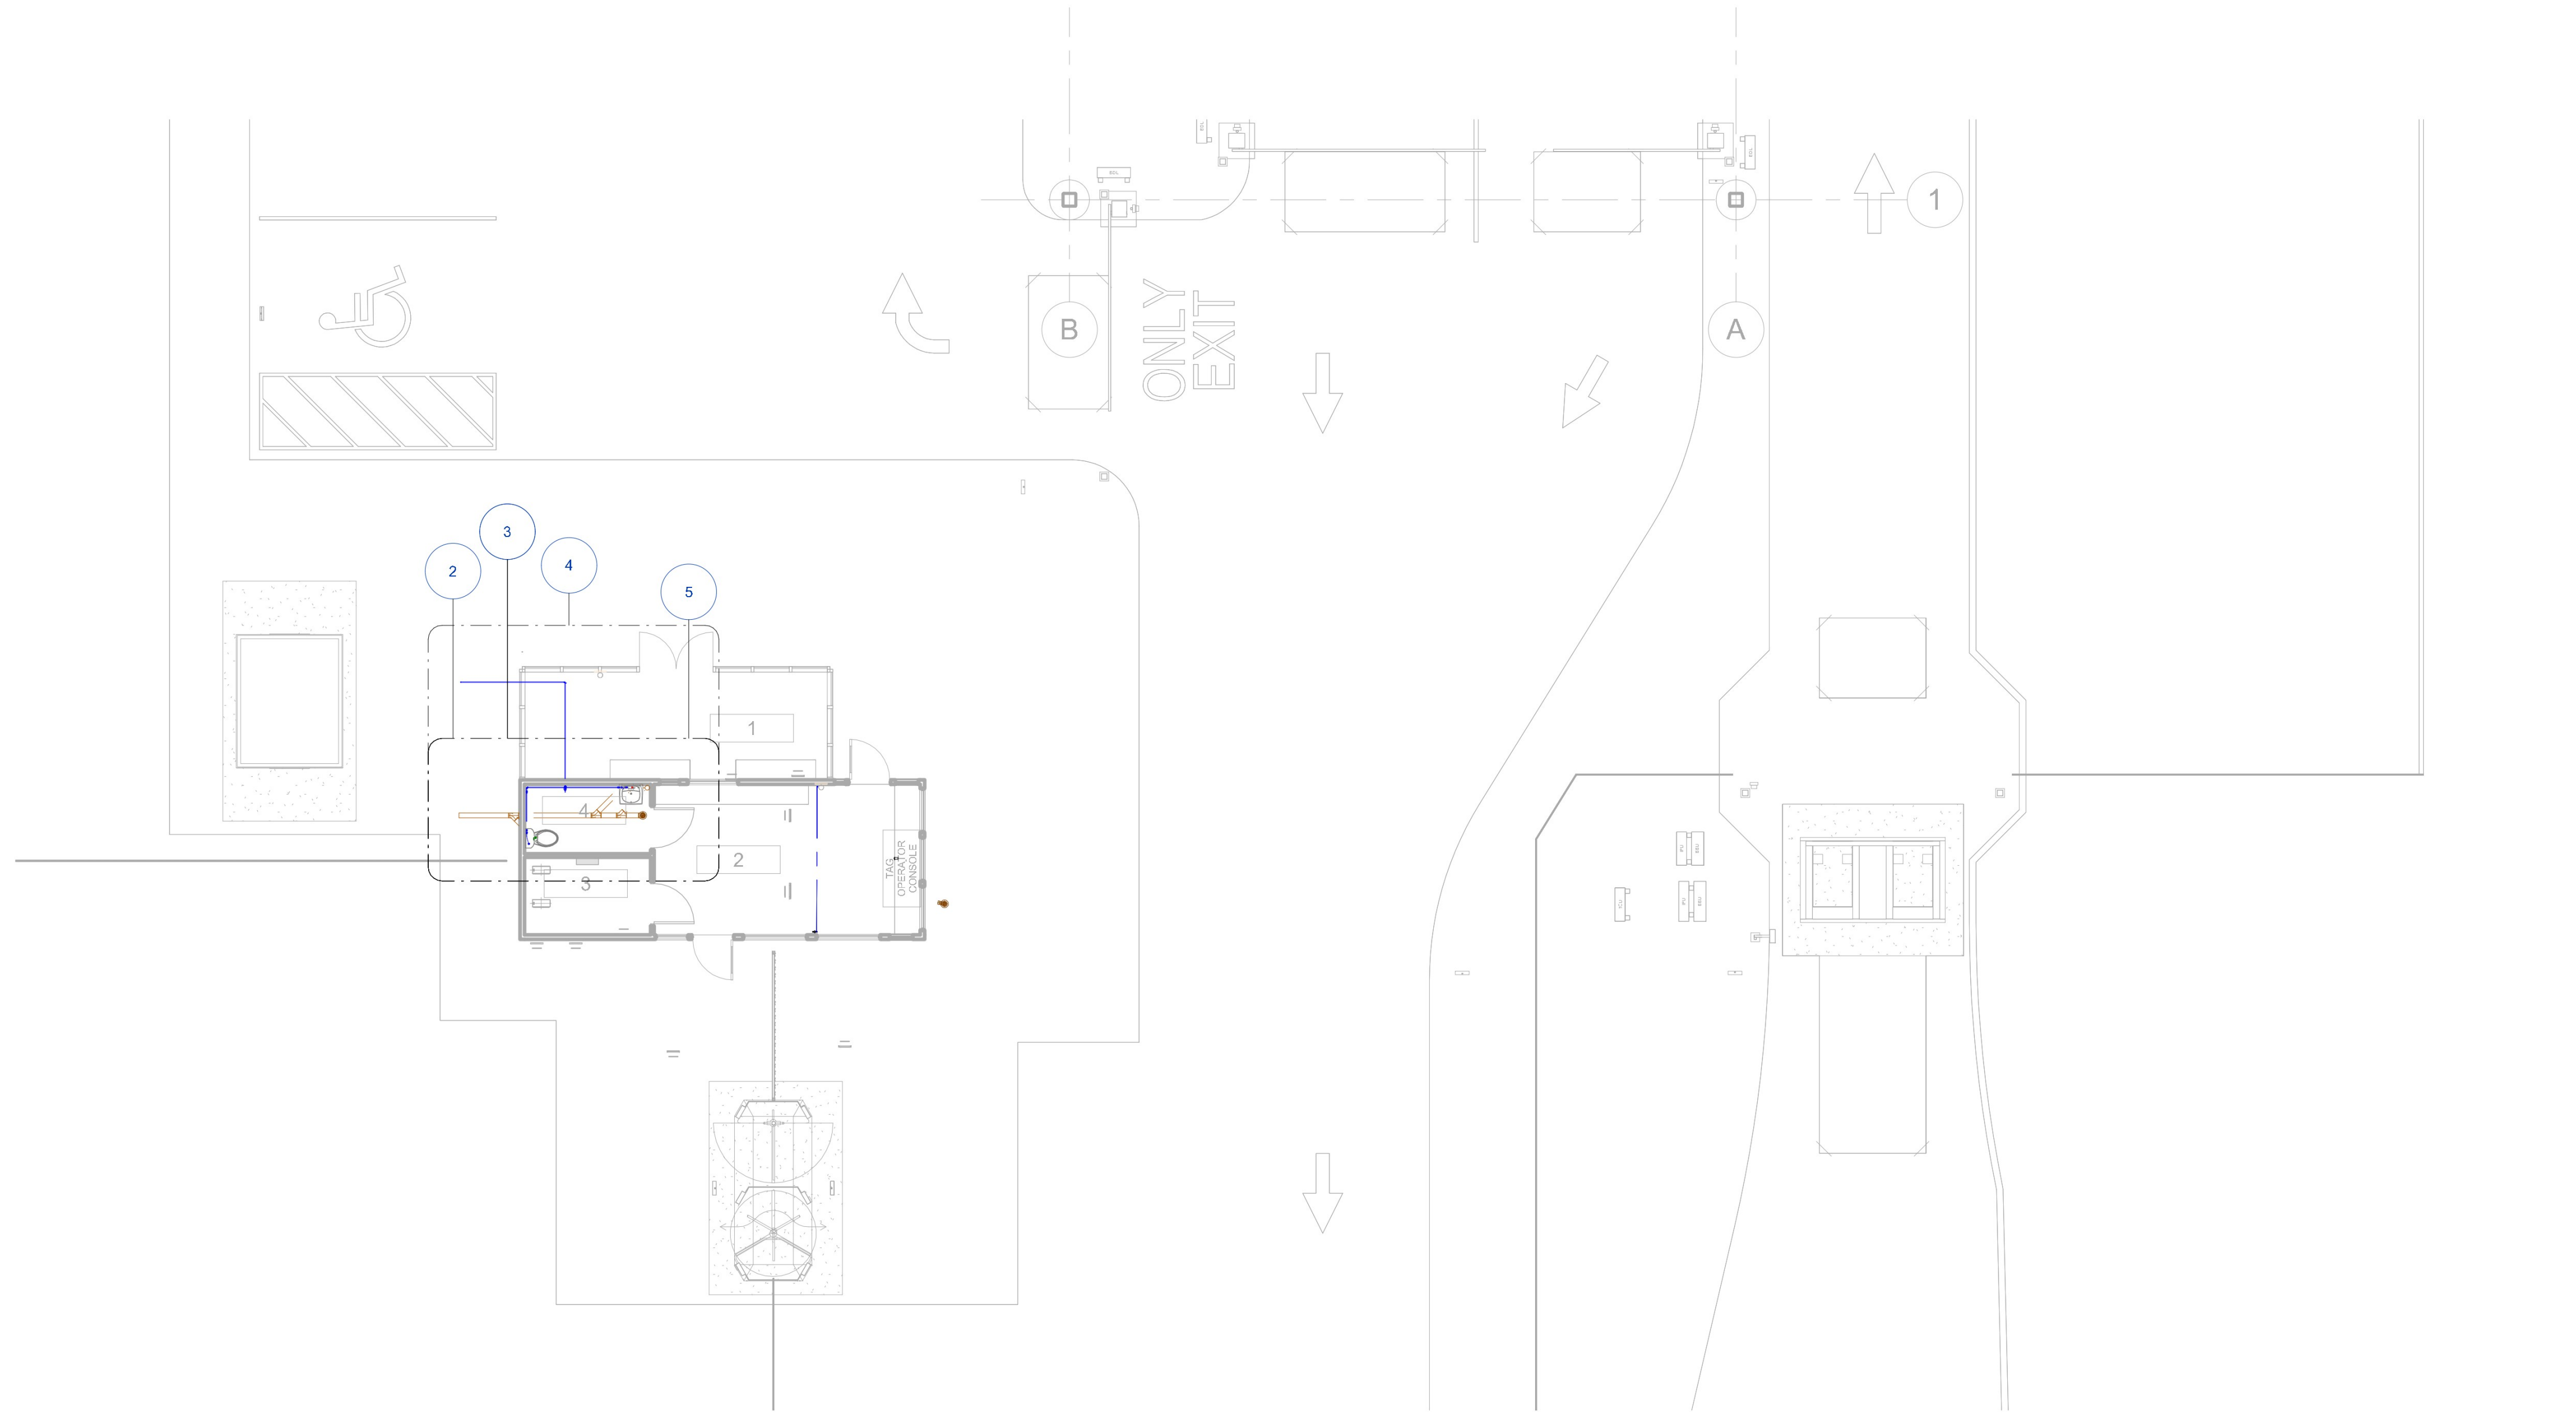


① NANO ENTRANCE PLUMBING SERVICES SITE PLAN / NANO ENTRANCE LEIDINGWERK SITUATIETEKENING
1 : 100

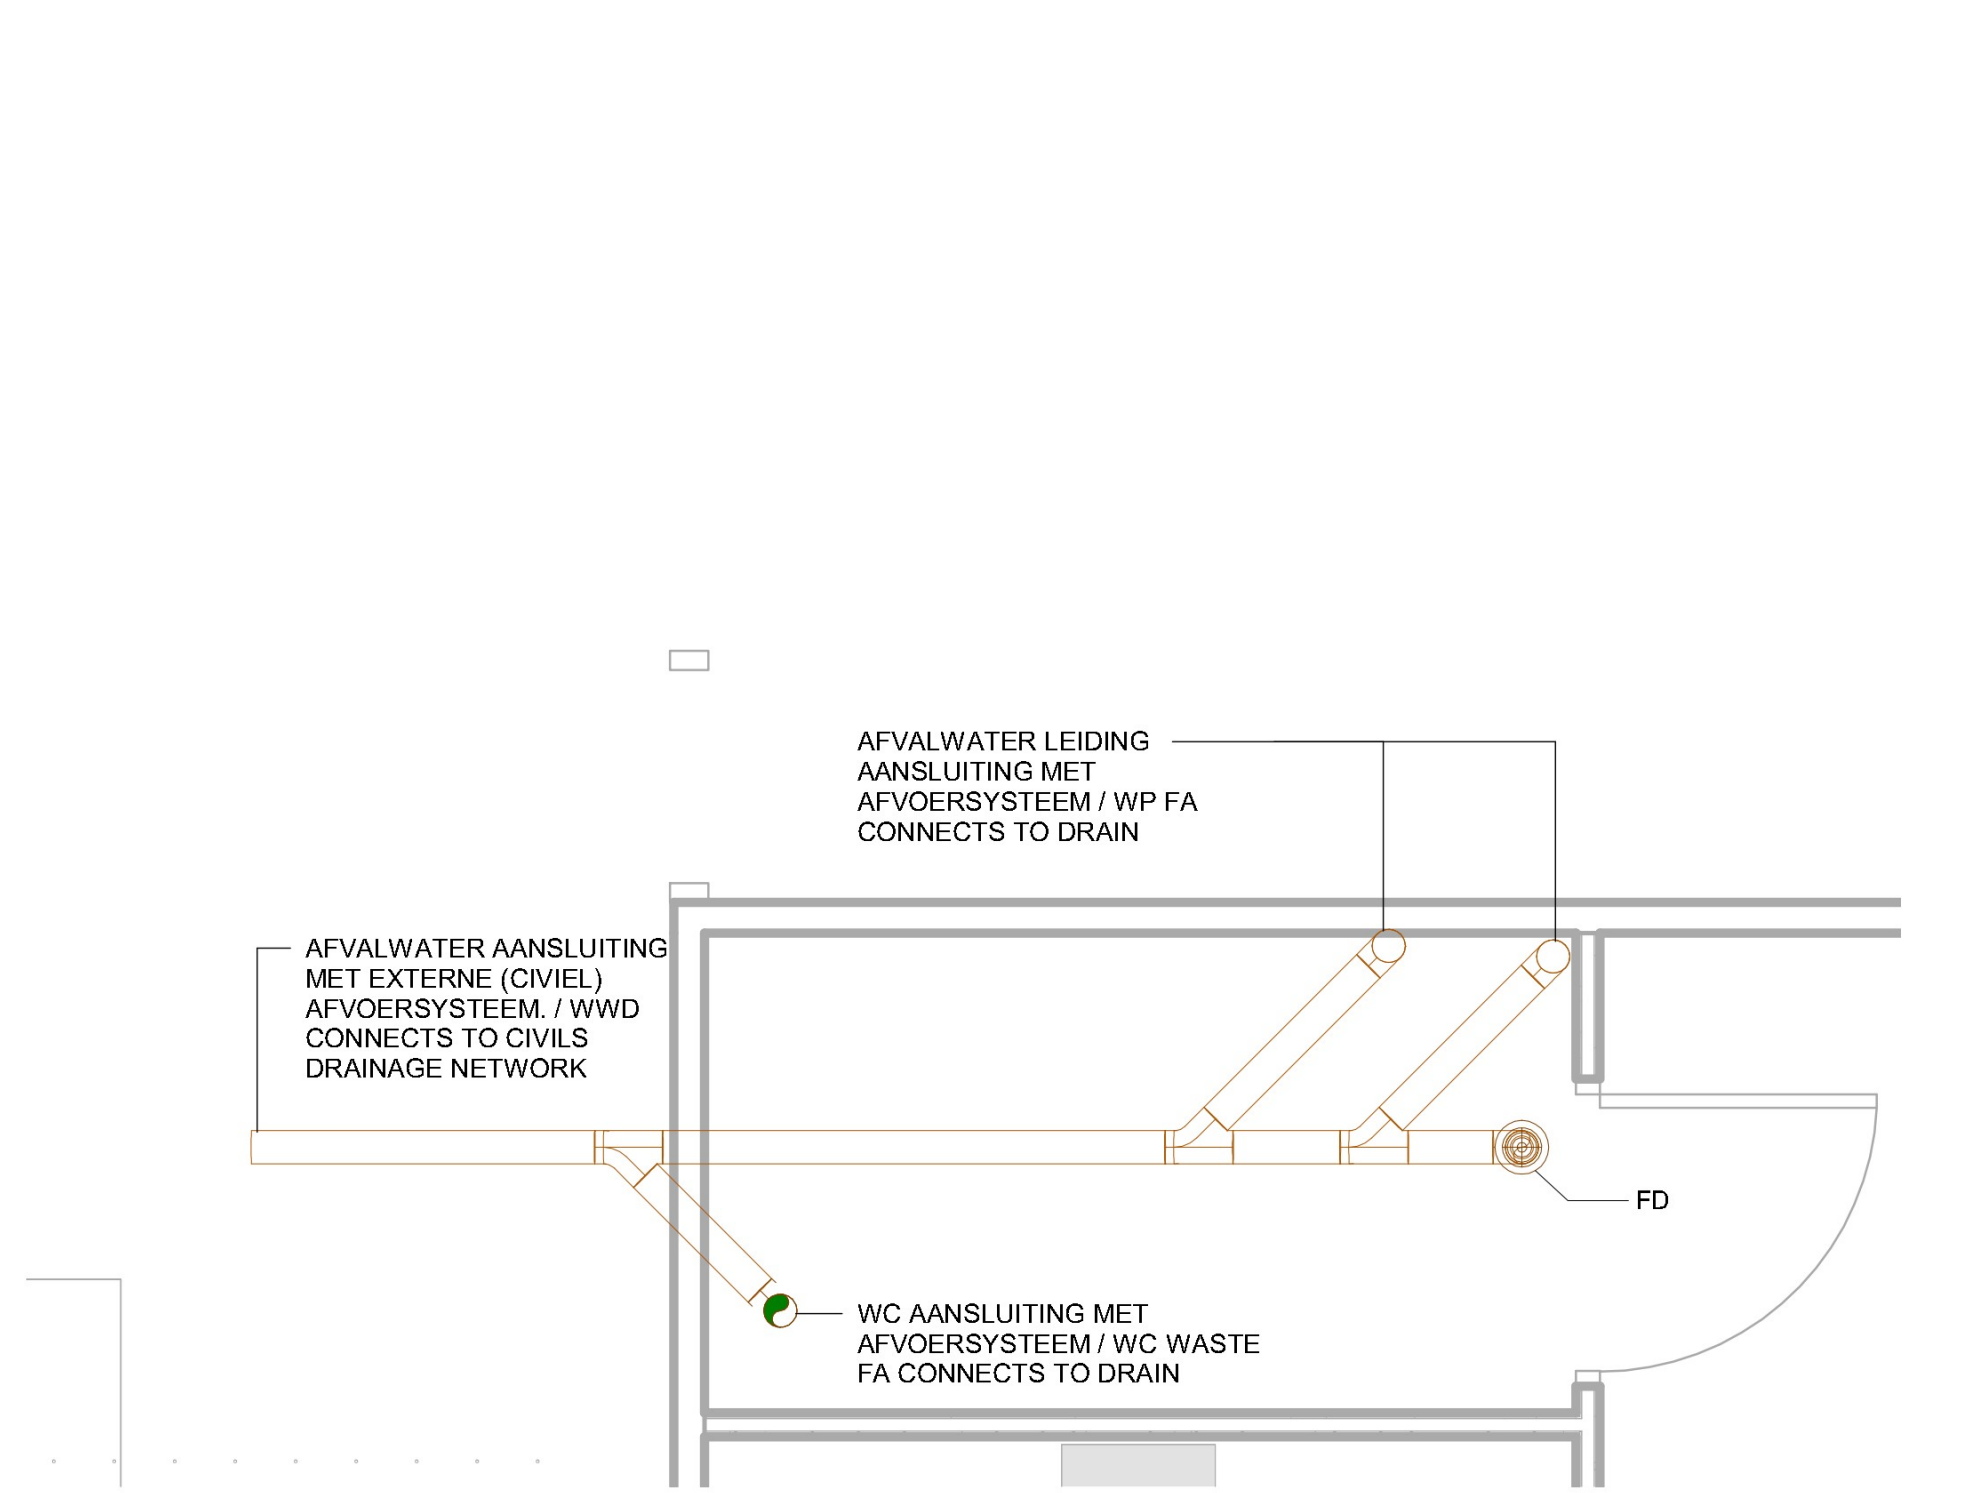


② PLUMBING BELOW GROUND PLAN - DRAINAGE / PLATTEGROND RIOLERIG (ONDERGRONDS)
1 : 25

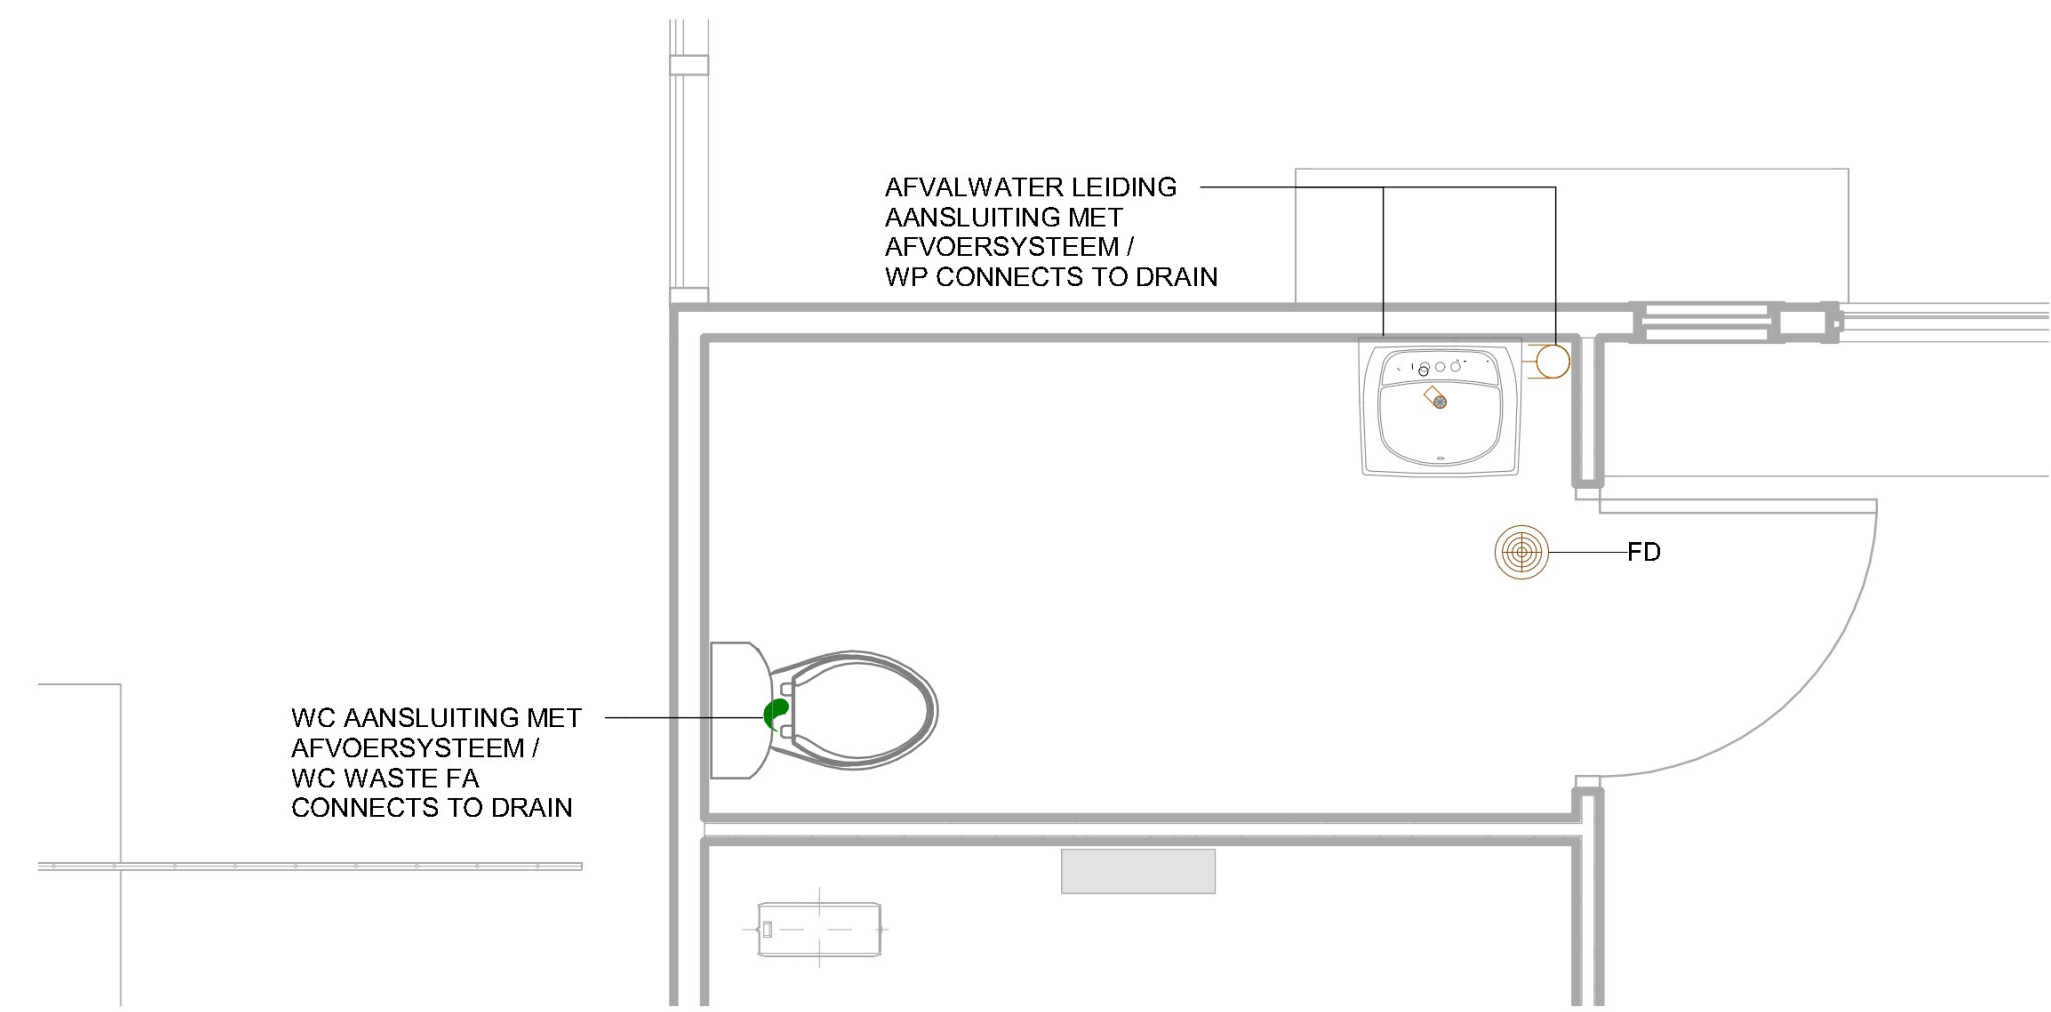

③ PLUMBING ABOVE GROUND PLAN - DRAINAGE / PLATTEGROND WATERAFVOER (BOVENGRONDS)
1 : 25

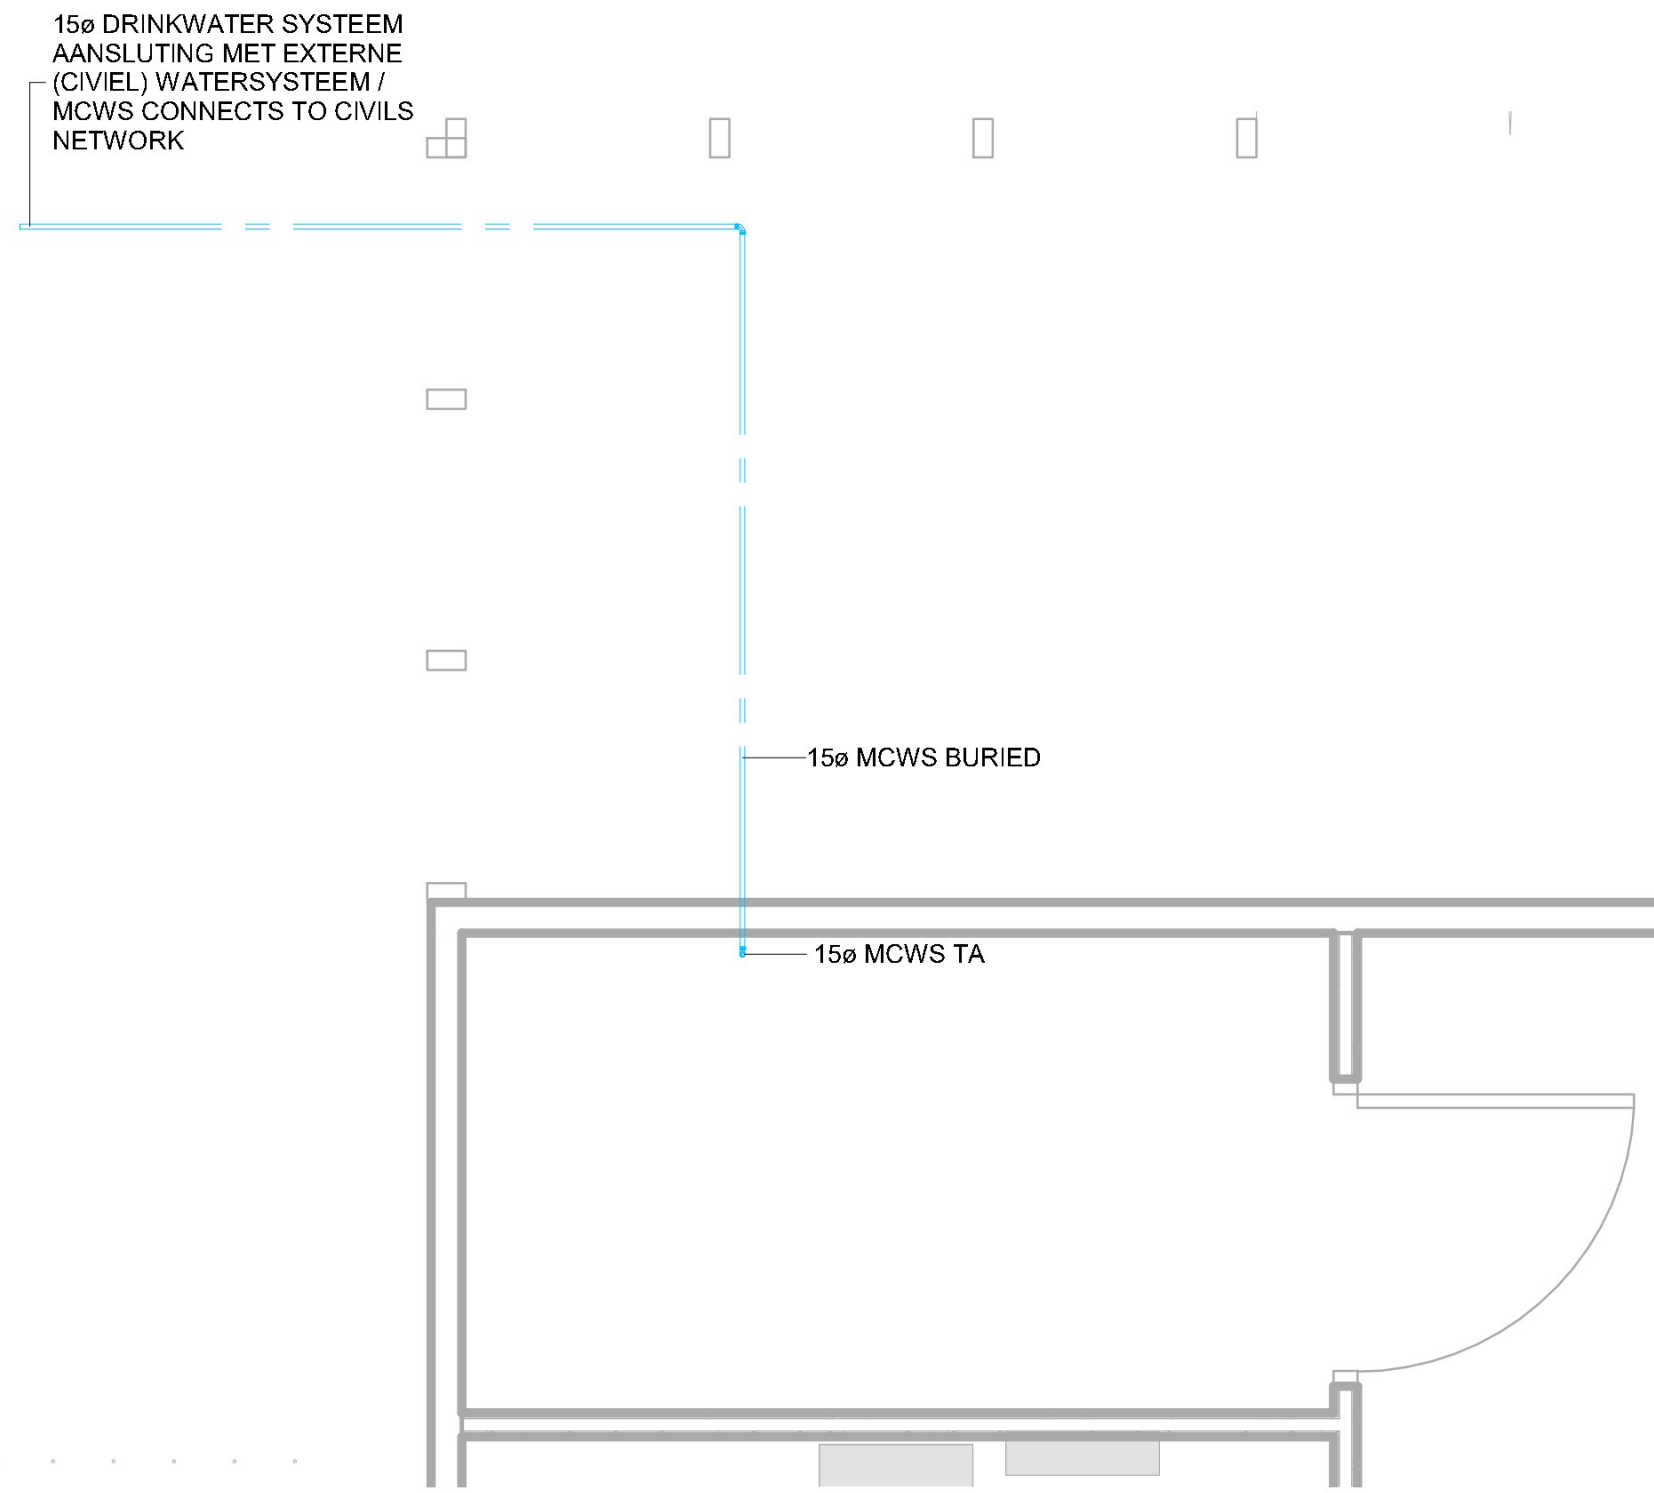

④ PLUMBING BELOW GROUND PLAN - WATER SERVICES / NANO ENTRANCE LEIDINGWERK SITUATIETEKENING
1 : 25

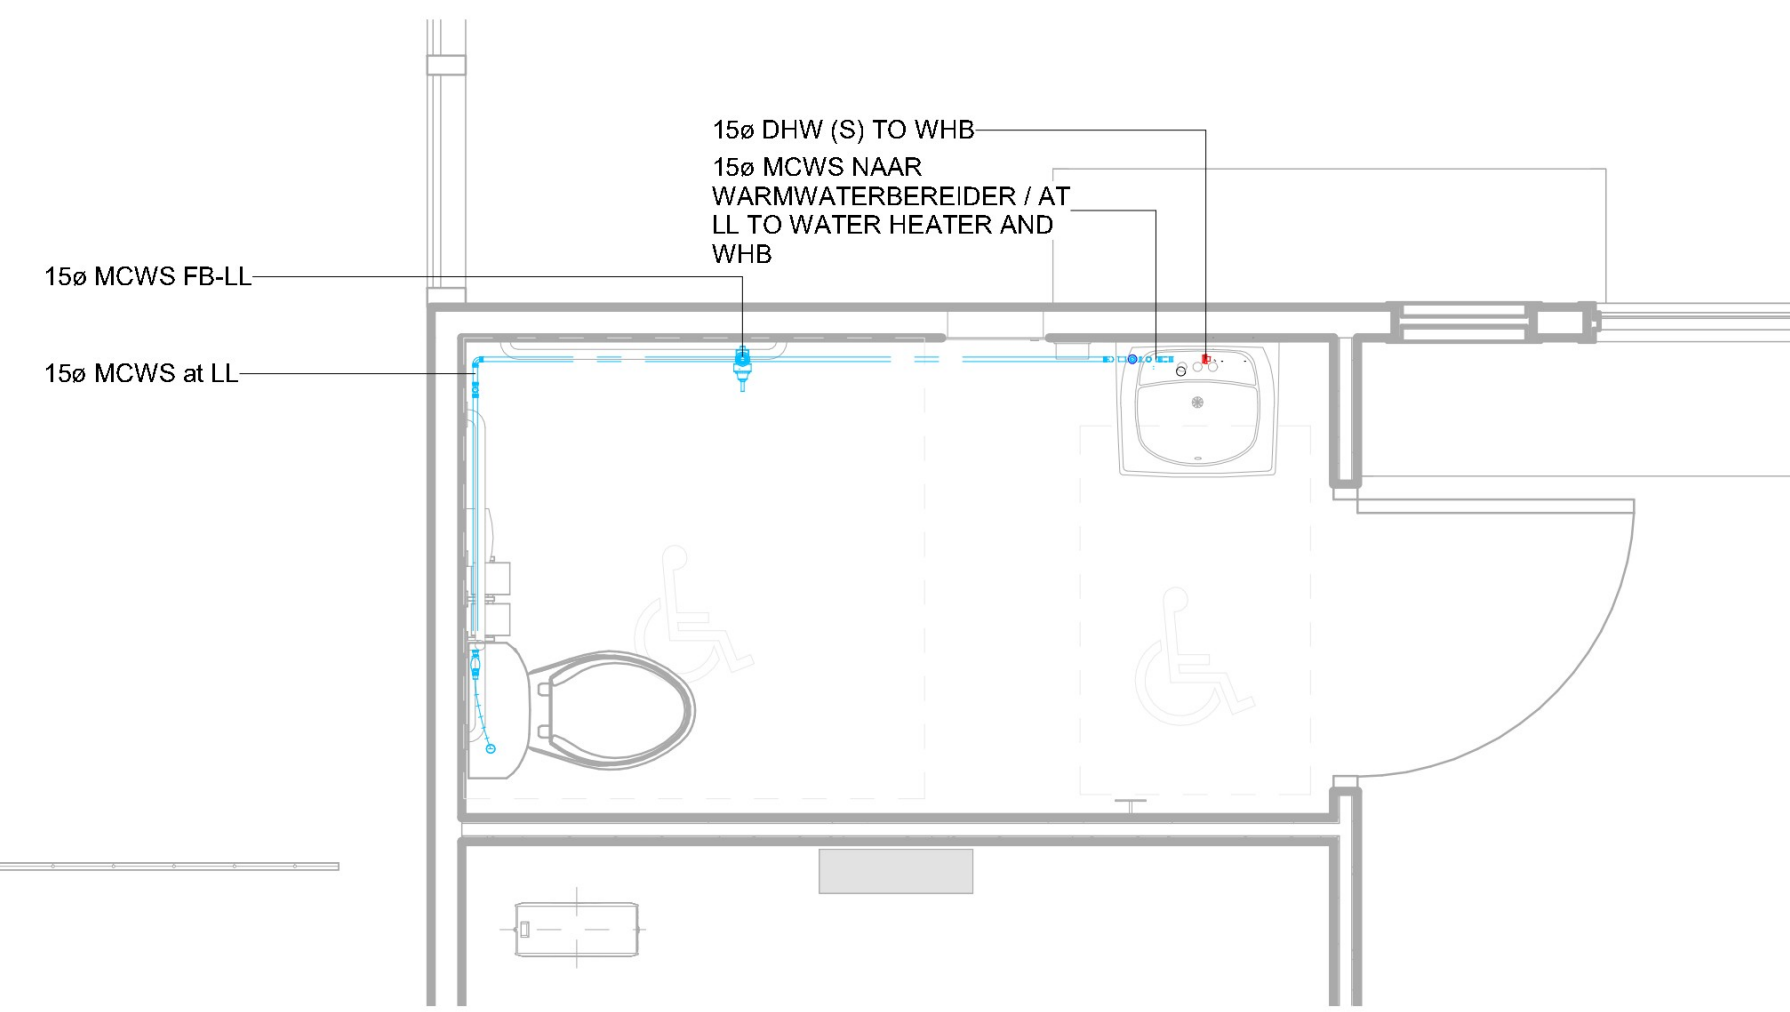

⑤ PLUMBING ABOVE GROUND PLAN - WATER SERVICES / PLATTEGROND WATERAANSLUITING (BOVENGRONDS)
1 : 25

LEGEND / LEGENDA

- Drinkwatervoorziening / Mains Cold Water Service - MCWS
- Warmwatervoorziening / Domestic Hot Water Supply - DHW(S)
- Afvalwaterafvoer / Waste Water Drainage - WP
- Ontspanningsleiding / Vent Pipe - VP
- FD: Vloer goot / Floor Drain
- WWD: Afvalwater goot / Waste Water Drain
- WP: Afvalwater leiding / Waste Pipe



BOUWKUNDIG / ARCHITECTURE:
Arup B.V.
Naritaweg 118
1043 CA
Amsterdam
The Netherlands

CONSTRUCTIE / STRUCTURE:
Arup B.V.
Naritaweg 118
1043 CA
Amsterdam
The Netherlands

INSTALLATIE TECHNISCH / MEP:
Arup B.V.
Naritaweg 118
1043 CA
Amsterdam
The Netherlands

ARUP

AANVRAAG OMGEVINGSVERGUNNING /
PERMITTING PACKAGE
(NIET VOOR UITVOERING / NOT FOR CONSTRUCTION)

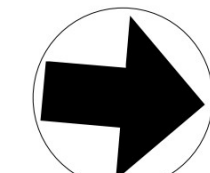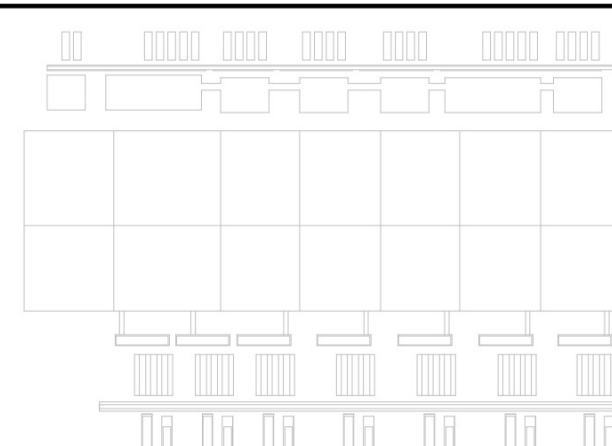

REVISIE / REVISIONS		
NR / NO.	DATUM / DATE	OMSCHRIJVING / DESCRIPTION
01	2022-06-16	Omgangsvergunning Definitief / WABO Permit Issue

Getekend /
Drawn By:
Gecontroleerd /
Checked By:
Goedgekeurd /
Approved By:

DC1A NANO
ENTRANCE

B. Haitzemastraat
9672 DC Winschoten
Netherlands
Project Nr. / Project No.: 286821-00

Bewakingsgebouw Begane Ground Riolerig /
Nano Entrance Ground Floor Plumbing

Discipline / Discipline:
PLUMBING

Schaal / Scale: As
Indicated

Formaat / Sheet Size: A0

Tekening Nummer / Sheet Number:

1A-P-1000X-SEC1-0

Huidige Revisie / Current Rev: 0.1
Fase / Phase: PERMITTING

Model Naam / Model Name: 1A-Nano Entrance
Bestandsformaat / Native File Format: Revit v. 2022.1