





SITE LOCATION / SITE LOCATIE
NTS

DRAWING LIST / TEKENINGENLIJST		
SHEET NUMBER/ BLAD NUMMEER	DESCRIPTION	BESCHRIJVING
1A-C-0010X-GENX-X	DRAWING LIST	TEKENINGENLIJST
1A-C-1010X-SDT0-X	SITE PLAN - EXISTING OVERALL	SITUATIE - BESTAAND TOTAAL
1A-C-1040X-SDT1A-X	SITE PLAN - PROPOSED OVERALL DAY N	SITUATIE - TOTAAL FASE 1-6
1A-C-1200X-SDT1A-X	COMBINED SERVICES BURIED LAYOUT	SITUATIE - GECOMBINEERDE ONDERGRONDE SERVICES
1A-C-1300X-SDT1A-X	SITE SURFACE TYPE LAYOUT	SITUATUE - TERREINOPPERVLAKTES
1A-C-1400X-SDT1A-X	DRAINAGE LAYOUT	RIOLERINGTEKENING
1A-C-1500X-SDT1A-X	WATER SERVICES LAYOUT	WATERAANSLUITING
1A-C-1600X-SDT1A-X	ELECTRICAL SERVICES LAYOUT	NUTSAANSLUITING ELEKTRA
1A-C-1650X-SDT1A-X	TELECOMS AND FIBRE LAYOUT	NUTSAANSLUITING TELECOM EN GLASVEZEL
1A-C-4000X-SDT1A-X	COMBINED SERVICES SECTIONS	DOORSNEDEN - GECOMBINEERDE SERVICES
1A-C-1000X-FSA1-0	FSA BELOW SLAB DRAINAGE LAYOUT	FSA PLATTEGROND ONDERGRONDSE RIOLERING
1A-C-1000X-DCH1A-0	DCH BELOW SLAB DRAINAGE LAYOUT	DCH PLATTEGROND ONDERGRONDSE RIOLERING

BOUWKUNDIG / ARCHITECTURE:	CONSTRUCTIE / STRUCTURE:	INSTALLATIE TECHNISCH / MEP:
Arup B.V. Naritaweg 118 1043 CA Amsterdam The Netherlands	Arup B.V. Naritaweg 118 1043 CA Amsterdam The Netherlands	Arup B.V. Naritaweg 118 1043 CA Amsterdam The Netherlands



AANVRAAG OMGEVINGSVERGUNNING /
PERMITTING PACKAGE
(NIET VOOR UITVOERING /NOT FOR CONSTRUCTION)

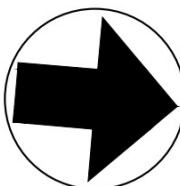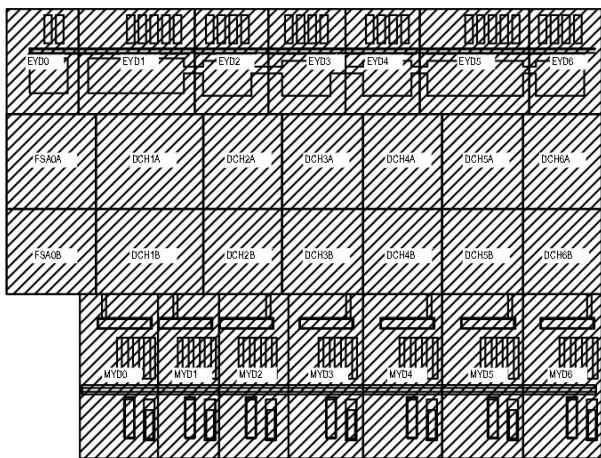

REVISIE / REVISIONS		
NR / NO	DATUM / DATE	OMSCHRIJVING / DESCRIPTION
0.1	2022-06-16	Omgangsvergunning Definitief: WABO Permit Issued

Getekend / Drawn By:
Gecontroleerd / Checked By:
Goedgekeurd / Approved By:

DC1A CIVIL
B. Halzemesstraat
9672 DC Winschoten
Netherlands

Project Nr. / Project No.: 286821-00

TEKENINGENLIJST
DRAWING LIST

Discipline / Discipline: Civil

Schaal / Scale: NTS Formaat / Sheet Size: A0

Tekening Nummer / Sheet Number:
1A-C-0010X-GENX-X

Huidige Revisie / Current Rev: 0.1
Fase / Phase: Permitting
Model Naam / Model Name: 1A-CIVIL
Bestandsformaat / Native File Format: Revit v. 2022.1